


DATE:
06/22/2021

JOB #6
REVISION:



COPY RIGHT ALL
RIGHTS RESERVED:

NEW BUILDING FOR:
NEW CONSESSION BUILDING
PIONEER SCHOOLS OKLAHOMA
3686 STATE HIGHWAY 92, OKLAHOMA 73018

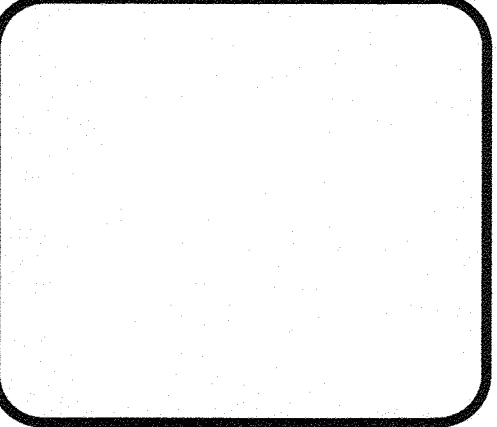

PLOT SCALE:
1/4" = 1'-0"

SHEET NO.:
M100

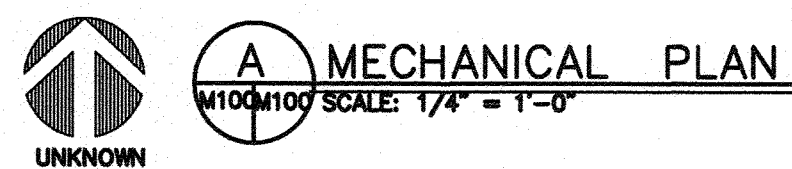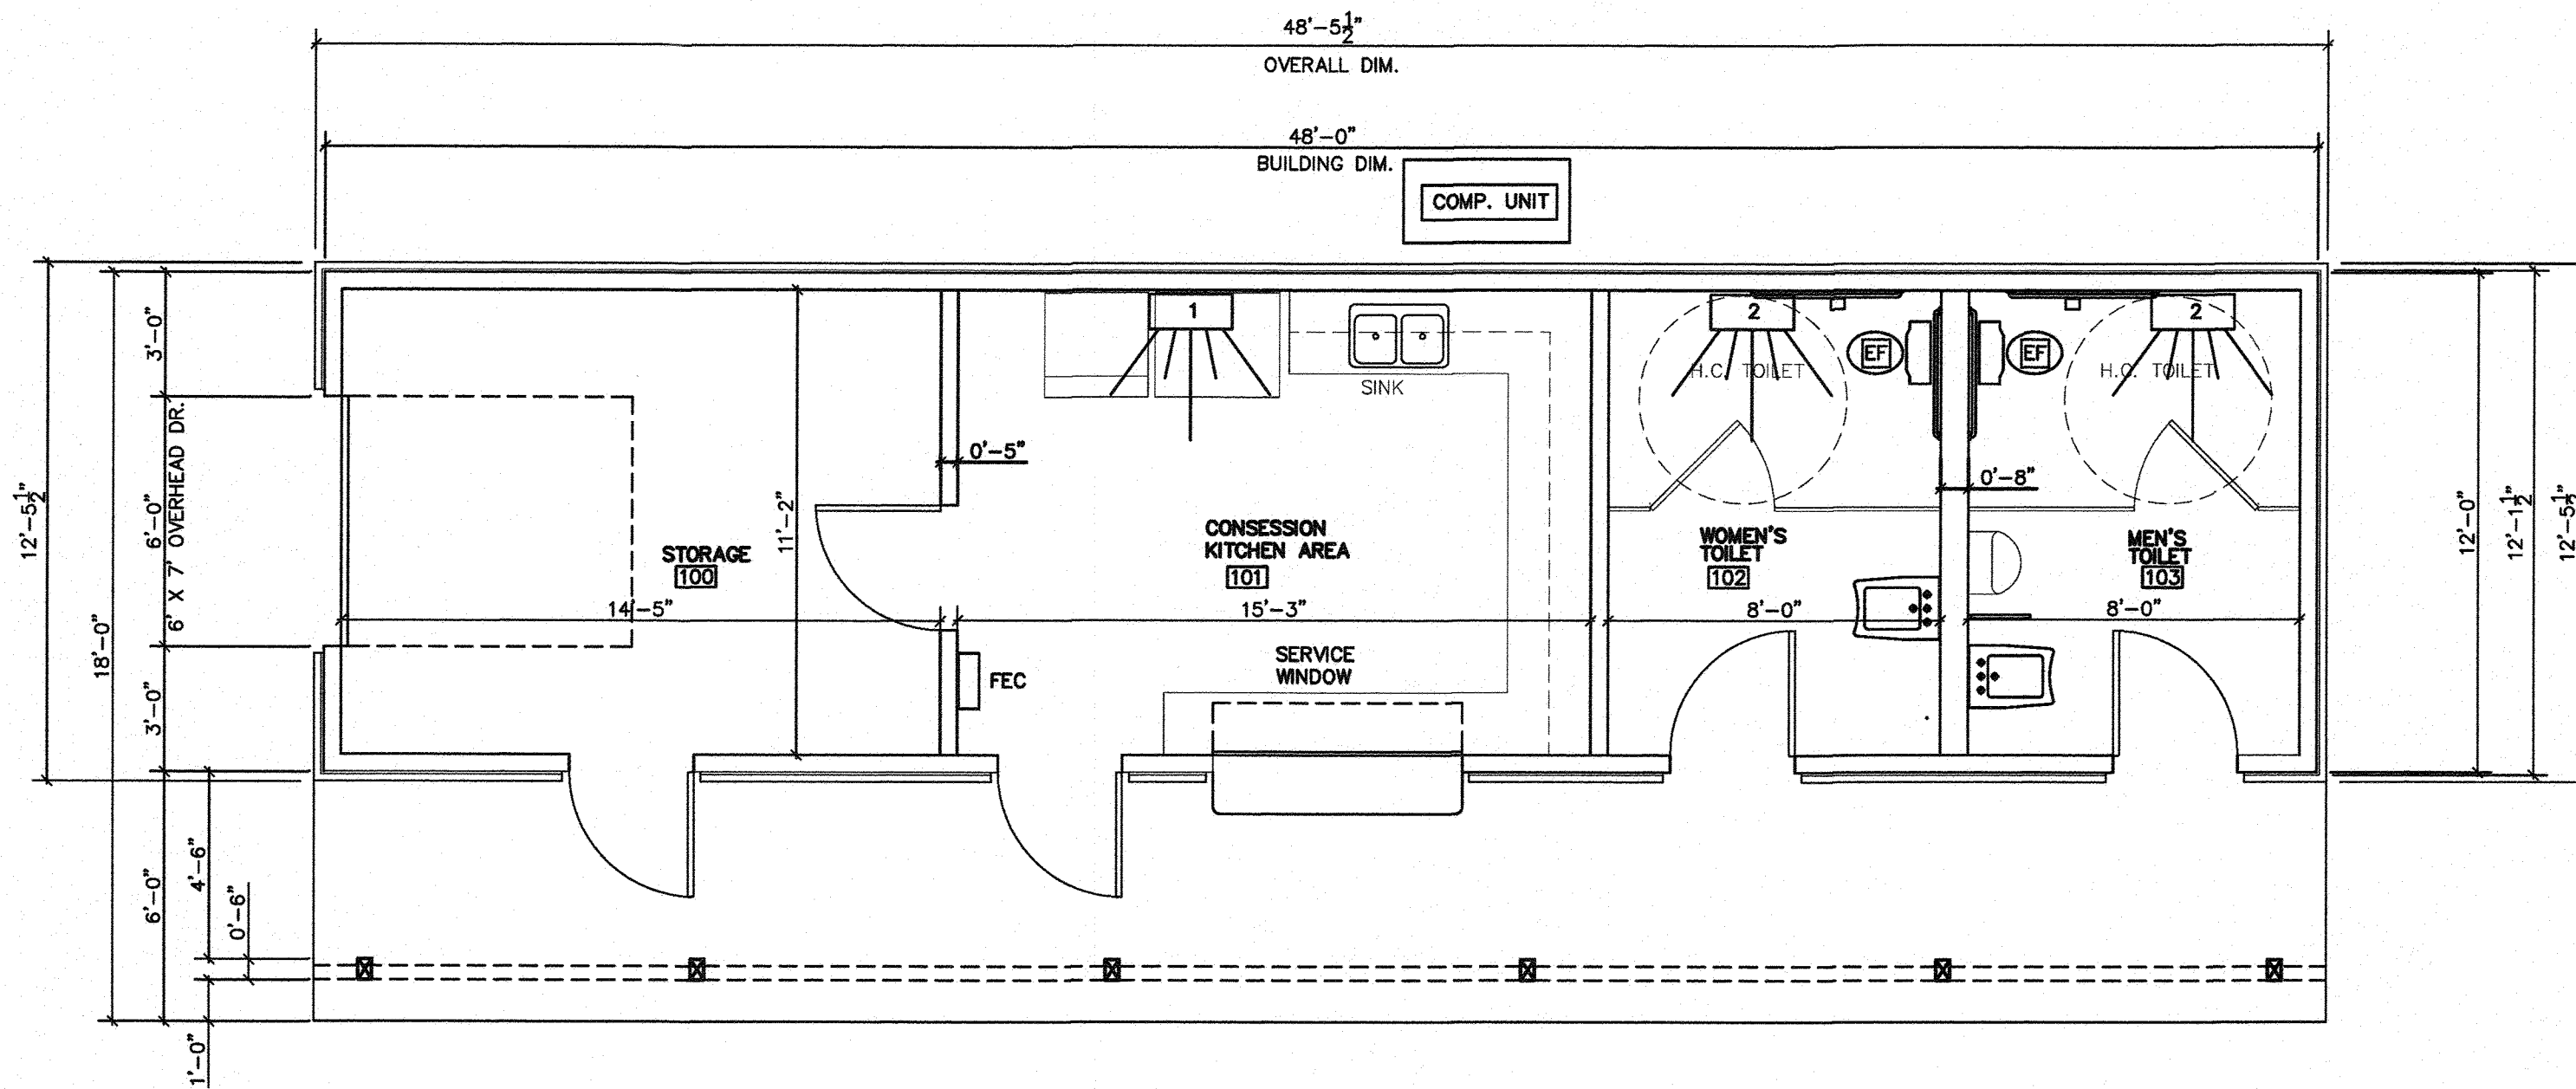

MECHANICAL SCHEDULE

EF EXHAUST FAN 100 CFM

COMP. UNIT COMPRESSOR UNIT TO SERVICE ALL MINI SPLITS MPB03054M - 1P

1 LENNOX OR EQUAL, MINI SPILT, MODEL MWMA01254 - 3P WALL PACK

2 LENNOX OR EQUAL, MINI SPILT, MODEL MWMA00954 - 3P WALL PACK