


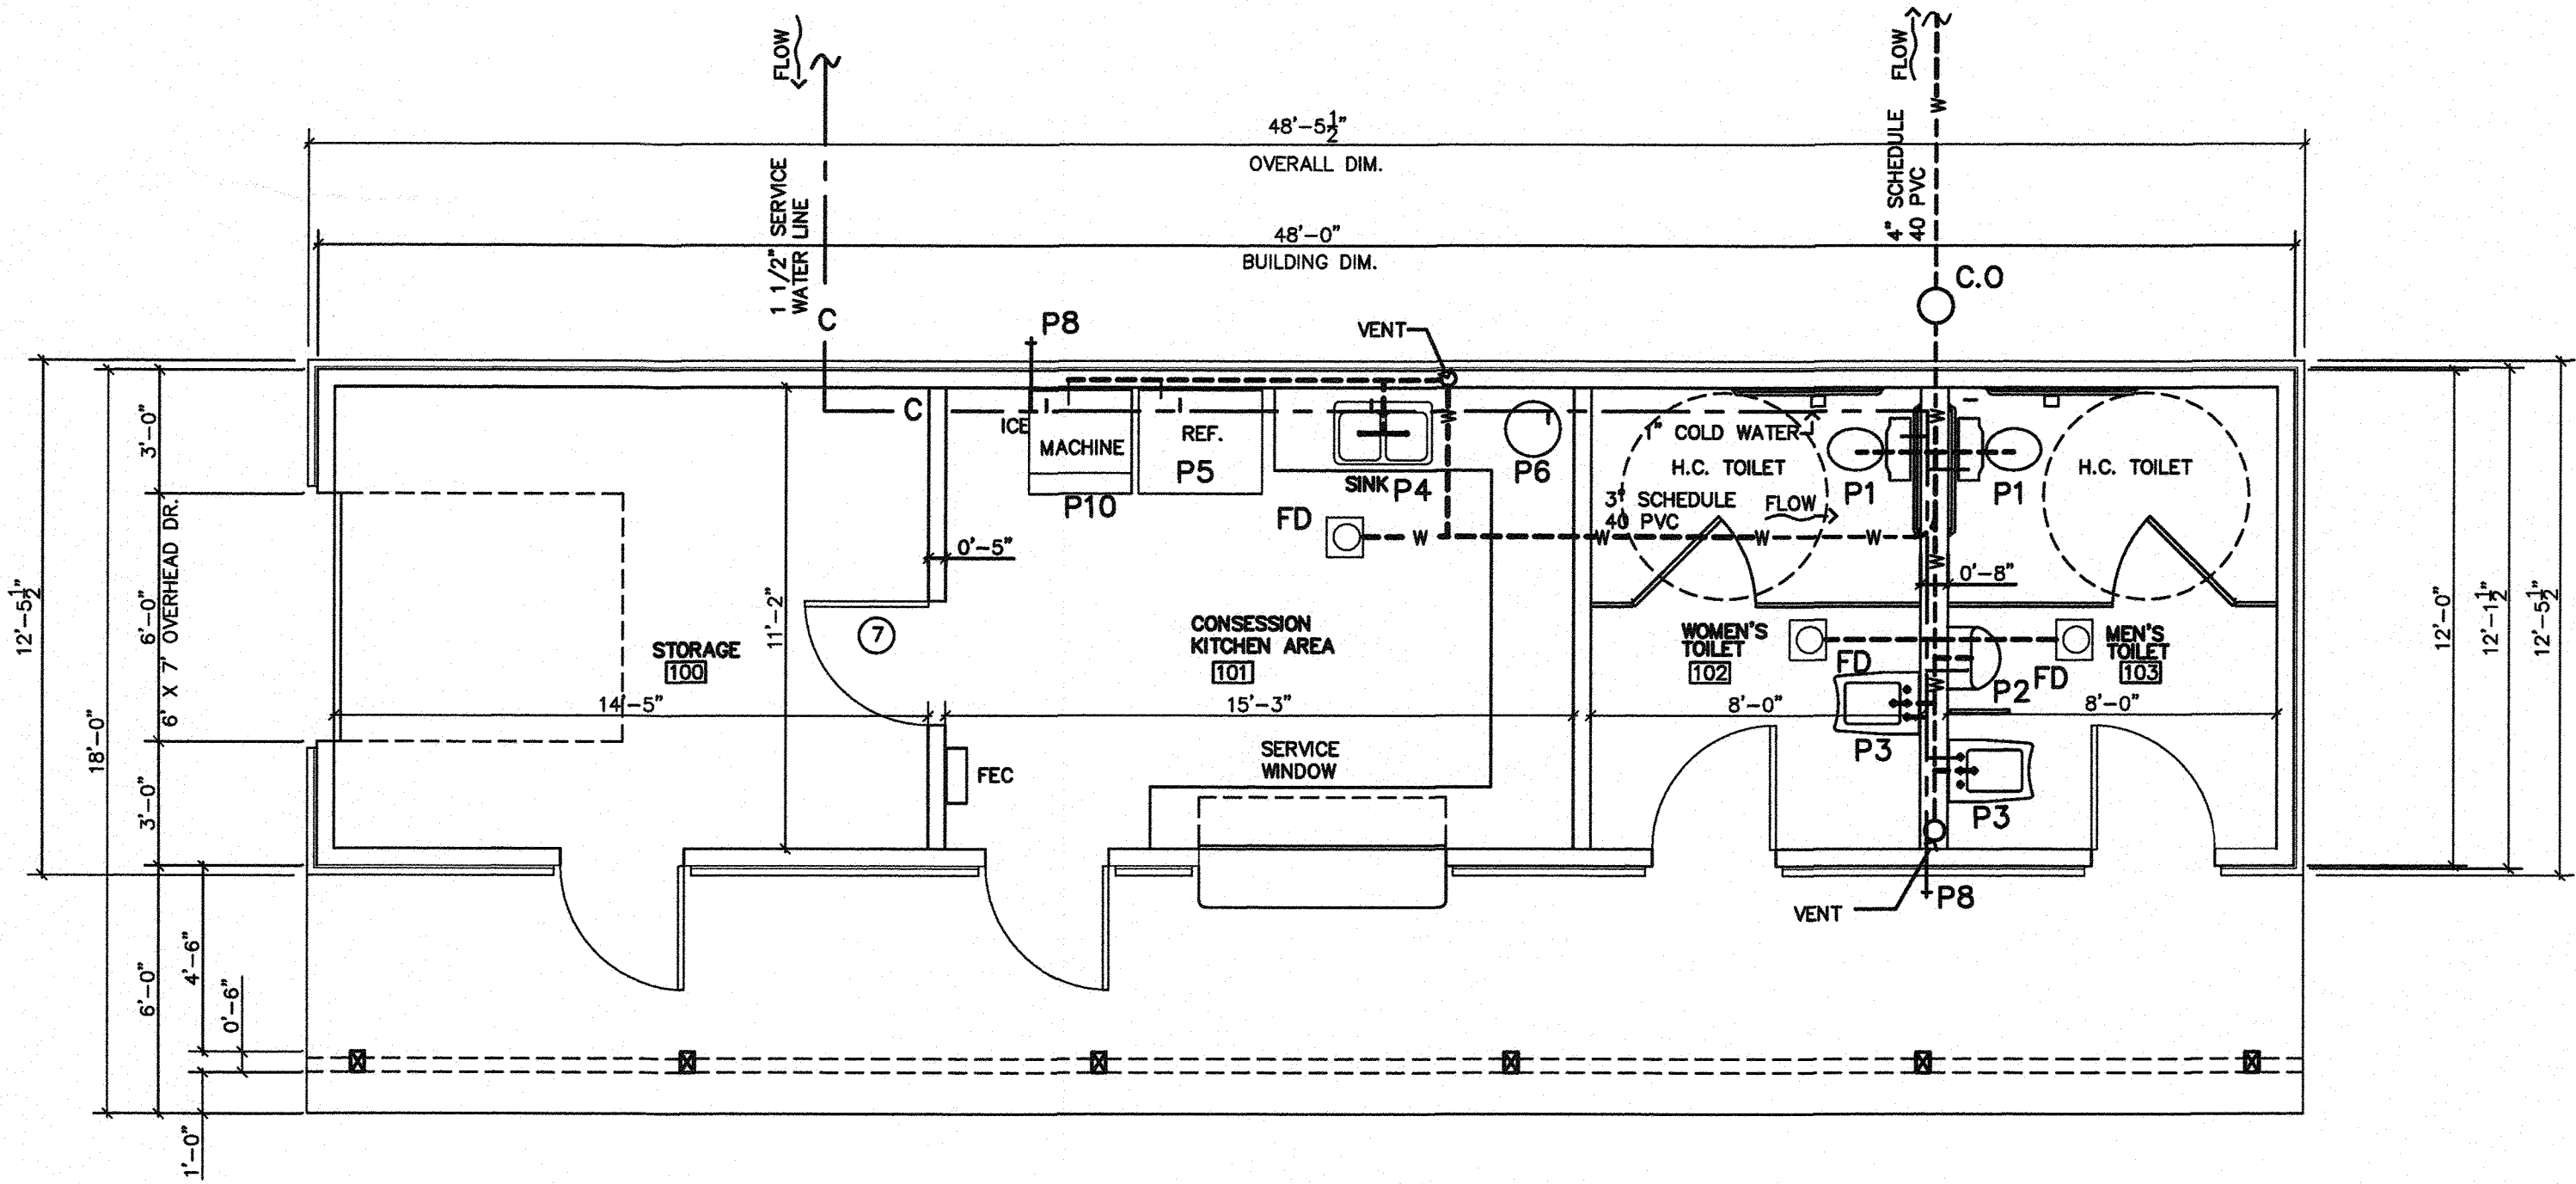

A PLUMBING PLAN
P100P100 SCALE: 1/4" = 1'-0"

LEGEND	
SYMBOL	DESCRIPTION
---W---	4" WASTE LINE SCHEDULE 40 PVC OR BETTER
—C—	1" COLD WATER LINE
—H—	HOT WATER LINE
VENT ○	2" VENT THROUGH ROOF
FD □	FLOOR DRAIN WITH A PEA TRAP TO PREVENT SEWER GAS FROM ENTERING THE BUILDING
C.O. ○	CLEAN OUT FOR SEWER LINE


PLUMBING SCHEDULE					
FIXTURE #	QTY.	DESCRIPTION	C.W.	H.W.	WASTE
P1	2	WATER CLOSET	1/2"	—	4"
P2	1	URINAL	1/2"	—	2"
P3	2	HANDICAPPED SINK	1/2"	1/2"	1 1/2"
P4	1	DEEP KITCHEN SINK	1/2"	1/2"	1 1/2"
P5	1	REFEGERATOR	1/2"	—	1"
P6	1	WATER HEATER 20 GAL	1 1/2"	—	1"
P7	0	JANITORIAL (SINK) OPT.	1/2"	1/2"	1 1/2"
P8	2	HOSE BIBB FROSTFREE	1"	—	—
P9	0	WATER FILTER AND SOFTNER (OPTIONAL)	2"	—	1"
P10	1	ICE MACHINE	1/2"	—	1"
P11					

DATE:
06/22/2021

JOB #6
REVISION:

COPY RIGHT ALL
RIGHTS RESERVED:

NEW BUILDING FOR:
NEW CONSESSION BUILDING
PIONEER SCHOOLS OKLAHOMA
3686 STATE HIGHWAY 92, OKLAHOMA 73018

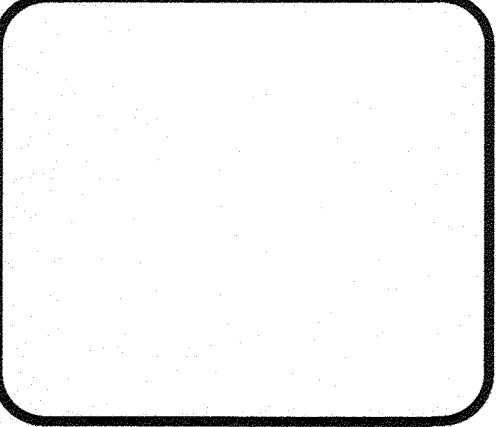

PLOT SCALE:
1/4" = 1'-0"

SHEET NO.:
P100